


- REFERENCE NOTES**
- 1 DEDICATED SWITCHES AT SHED AND LOCK ROOMS IN FLOOR RECESS LIGHTS
 - 2 OCCUPANCY SENSORS LOCATED IN RESTROOMS - 2 PER RESTROOM. (OWNER TO VERIFY)
 - 3 EXHAUST FAN AT EACH WALKER CLOSET

ELECTRICAL/MECHANICAL NOTES

- 400 AMP SERVICE - LOCATE AND INSTALL TO LOCAL ELECTRICAL CO. SPECS SUB PANEL LOCATED PER PLANS
- DRIVE ROD AT SERVICE LOCATION
- ALL REFRIG. COILS LOCATED IN KITCHEN AND FLOOR RECESS LIGHTS IN HALLWAYS
- SMOKE DETECTORS LOCATED IN HALLWAYS
- SMOKE DETECTORS TO BE HARD WIRED W/ BATTERY BACKUP
- PROVIDE 220 SERVICE TO RANGE, WATER HEATER, DISHWASHER, A/C CONDENSER AND CLOTHES DRYER
- PROVIDE SEPARATE 20 AMP CIRCUIT TO REFRIGERATOR AND ANY OTHER MAJOR APPLIANCES
- EXTEND EXHAUST FANS AND KITCHEN HOOD TO EXTERIOR THRU ROOF
- HEAVY COOLING SYSTEM TO BE INSTALLED BY LICENSED PROFESSIONAL CONTRACTOR
- FIRE ALARM SYSTEM TO BE INSTALLED BY LICENSED PROFESSIONAL CONTRACTOR
- ALL STROGES TO BE LOCATED IN COMPLIANCE WITH MOST RECENT NFPA AND ADA SPECIFICATIONS

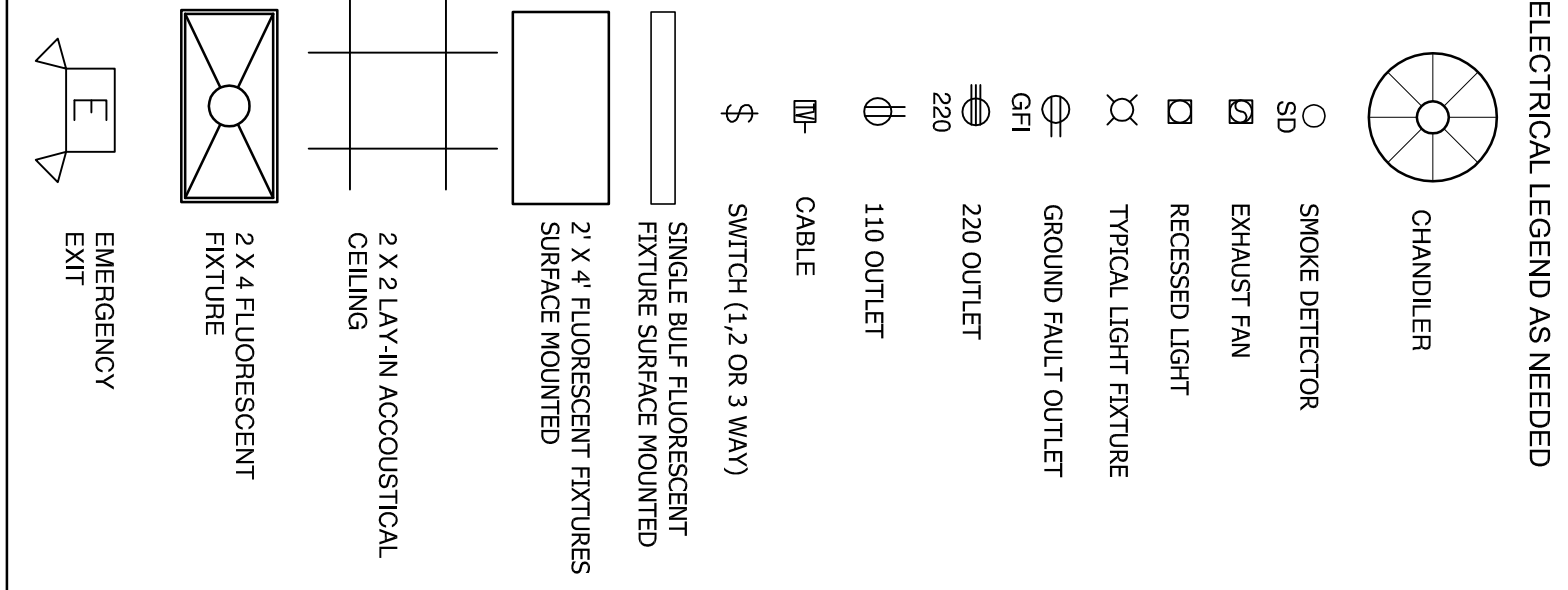

1 MAIN FLOOR ELECTRICAL PLAN

SCALE NOTES

PRELIMINARY
NOT FOR CONSTRUCTION

LAKESHORE BAPTIST CHURCH
FELLOWSHIP HALL AND
CLASSROOMS

MAIN FLOOR ELECTRICAL PLAN

DATE: 07/28/11
SCALE: 3/16"=1'-0"
DRAWN BY: M. MADISON
JOB: 2011-01